

AREA CALCULATION
 CUSTOMER AREA - 40.49 Sqm
 BANKING AREA - 48.82 Sqm
 RECORD/DINING/UPS-25.24Sqm
 STRONG ROOM - 11.15Sqm
 ATM - 4.99Sqm
TOTAL - 130.69 Sqm
 - 1406.22 Sft

Revisions

Rev. Date	Remarks	Sign	Check

Scale	Date
: NTS	: 22-01-2025
S.No. :	Drawn By: Sujish
Checked :	Job no :
Drawing No : 1	

DC ALL DIMENSIONS ARE IN CENTIMETERS

Name of work: FINAL LAYOUT

Title :

Clients Signature-


Client:
 Bank of Baroda
 Branch Office
 Aroor


Architects Signature & seal :-

Architect:


PrimaArch

Head office
 (Architect, CA-84 8733, REG Value-F-3047)
 359 - E, 1st Floor
 Convent Road, Cherthala - 688 524
 PH - 0478 - 2820159
 E-mail primaarch@gmail.com

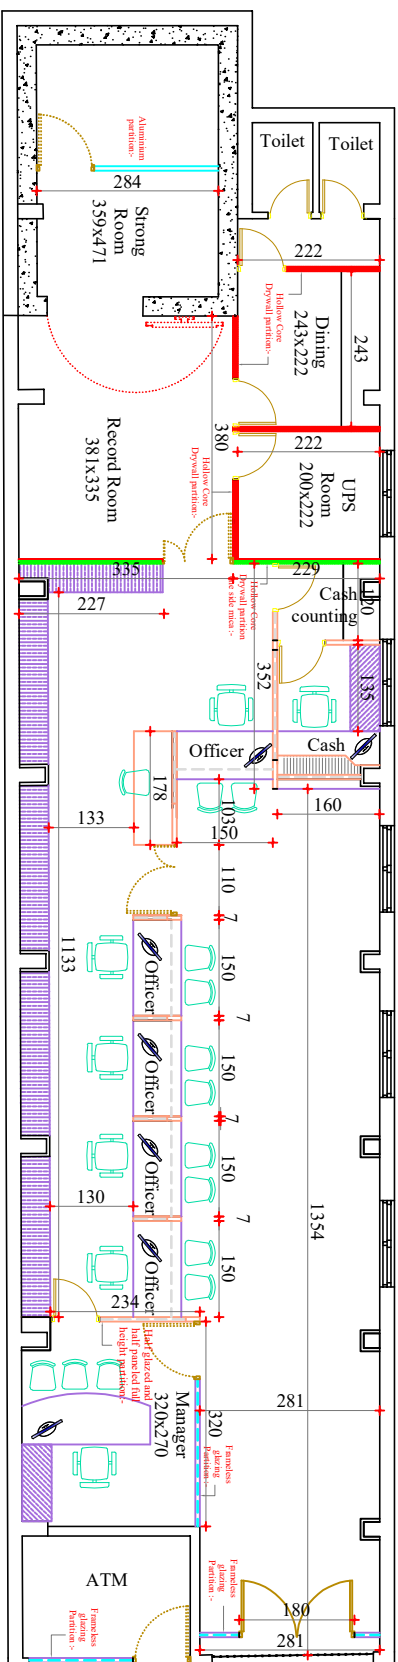

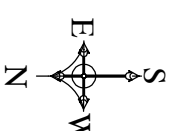

AREA CALCULATION
 CUSTOMER AREA - 40.49 Sqm
 BANKING AREA - 48.82 Sqm
 RECORD/DINING/UPS-25.24Sqm
 STRONG ROOM - 11.15Sqm
 ATM - 4.99Sqm
TOTAL - 130.69 Sqm
 - 1406.22 Sft

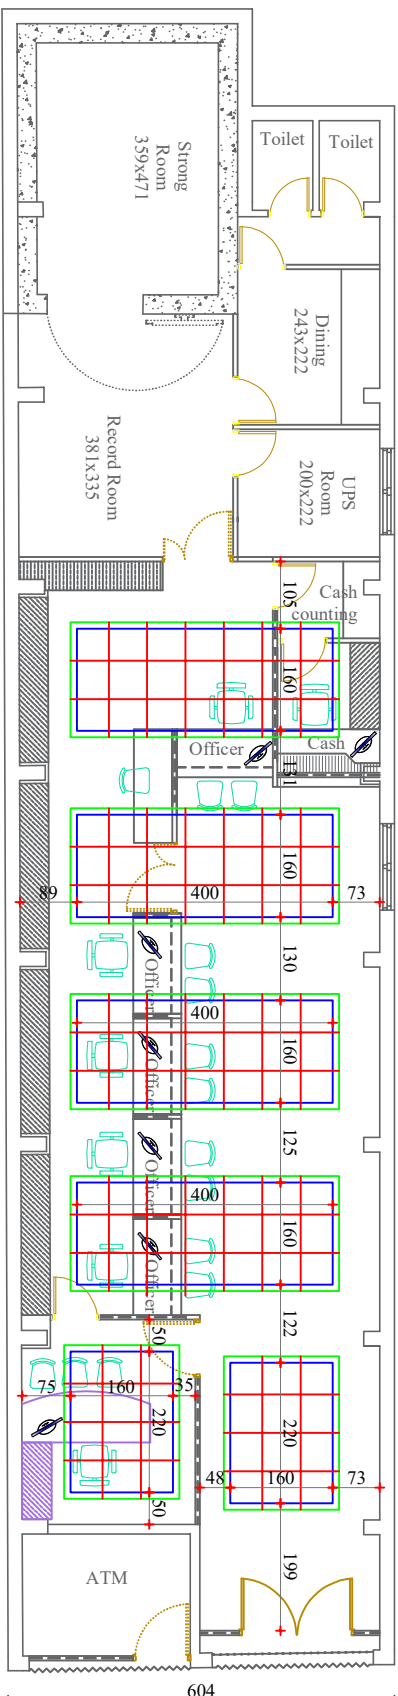

Revisions

Rev. Date	Remarks	Sign	Check

Scale : NTS	Date : 22-01-2025
S.No. :	Drawn By: Sujash
Checked :	Job no. :
Drawing No. : 1	

DC ALL DIMENSIONS ARE IN CENTIMETERS

CEILING LAYOUT

Name of work: _____

Title: _____



Clients Signature: _____

Client: **Bank of Baroda**
Branch Office
Aroor

Architects Signature & seal :- _____

Architect: *Prima's Arch*

Head office
 (Architect, CA-84 8733, REG Value-F-3047)
 559 - E, 1st Floor
 Convent Road, Cherthala - 688 524
 PH - 0478 - 2820159
 E-mail primaarch@gmail.com

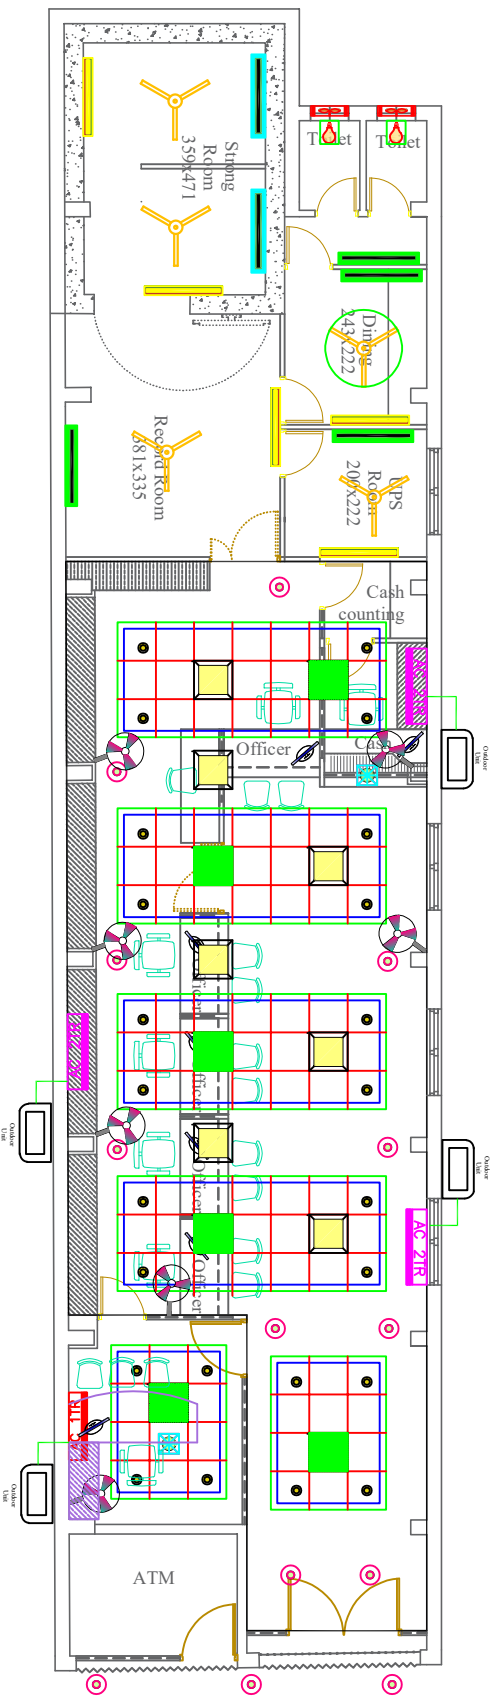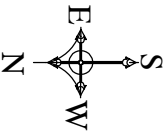

Rev.	Date	Remarks	Sign	Check

●	1.5W ROUND LED FITTING	24
■	3W LED FITTING	7
■	3W LED FITTING FROM INVERTER	6
▲	LED bulb FROM INVERTER	2
—	LED TUBE FITTING	5
—	LED TUBE FITTING FROM INVERTER	4
—	LED TUBE FITTING FROM UPS	2
—	12" EXHAUST FAN	2
—	120WMM CEILING FAN	4
—	120WMM CEILING FAN FROM INVERTER	1
—	CORN FAN	
—	WALL FAN FROM INVERTER	7
—	STRIP LED	62M
—	1x1.8 ROUND FITTING	13
—	1x1.8 ROUND FITTING FROM INVERTER	
—	1x1.8 ROUND FITTING FROM UPS	2
■	2 TONE AC	3
■	1.5TONE AC	0
■	1.0TONE AC	1

Scale : NTS Date : 22-01-2025

S.No. : Draft :

Checked : Drawn By: AML

Drawing No : 1 Job no :

DC ALL DIMENSIONS ARE IN CENTIMETERS

Name of work: Electrical Layout RAW

Client: Bank of Baroda
Branch Office
Aroor

Architect's Signature & seal :-

Architect: *Prima'shah*

Head office
(Architect, CA-84 8733, REG Value-F: 3047)
559 - E, 1st Floor
Convent Road, Cherthala - 688 524
PH - 0478 - 2820159
E-mail: primaarch@gmail.com