


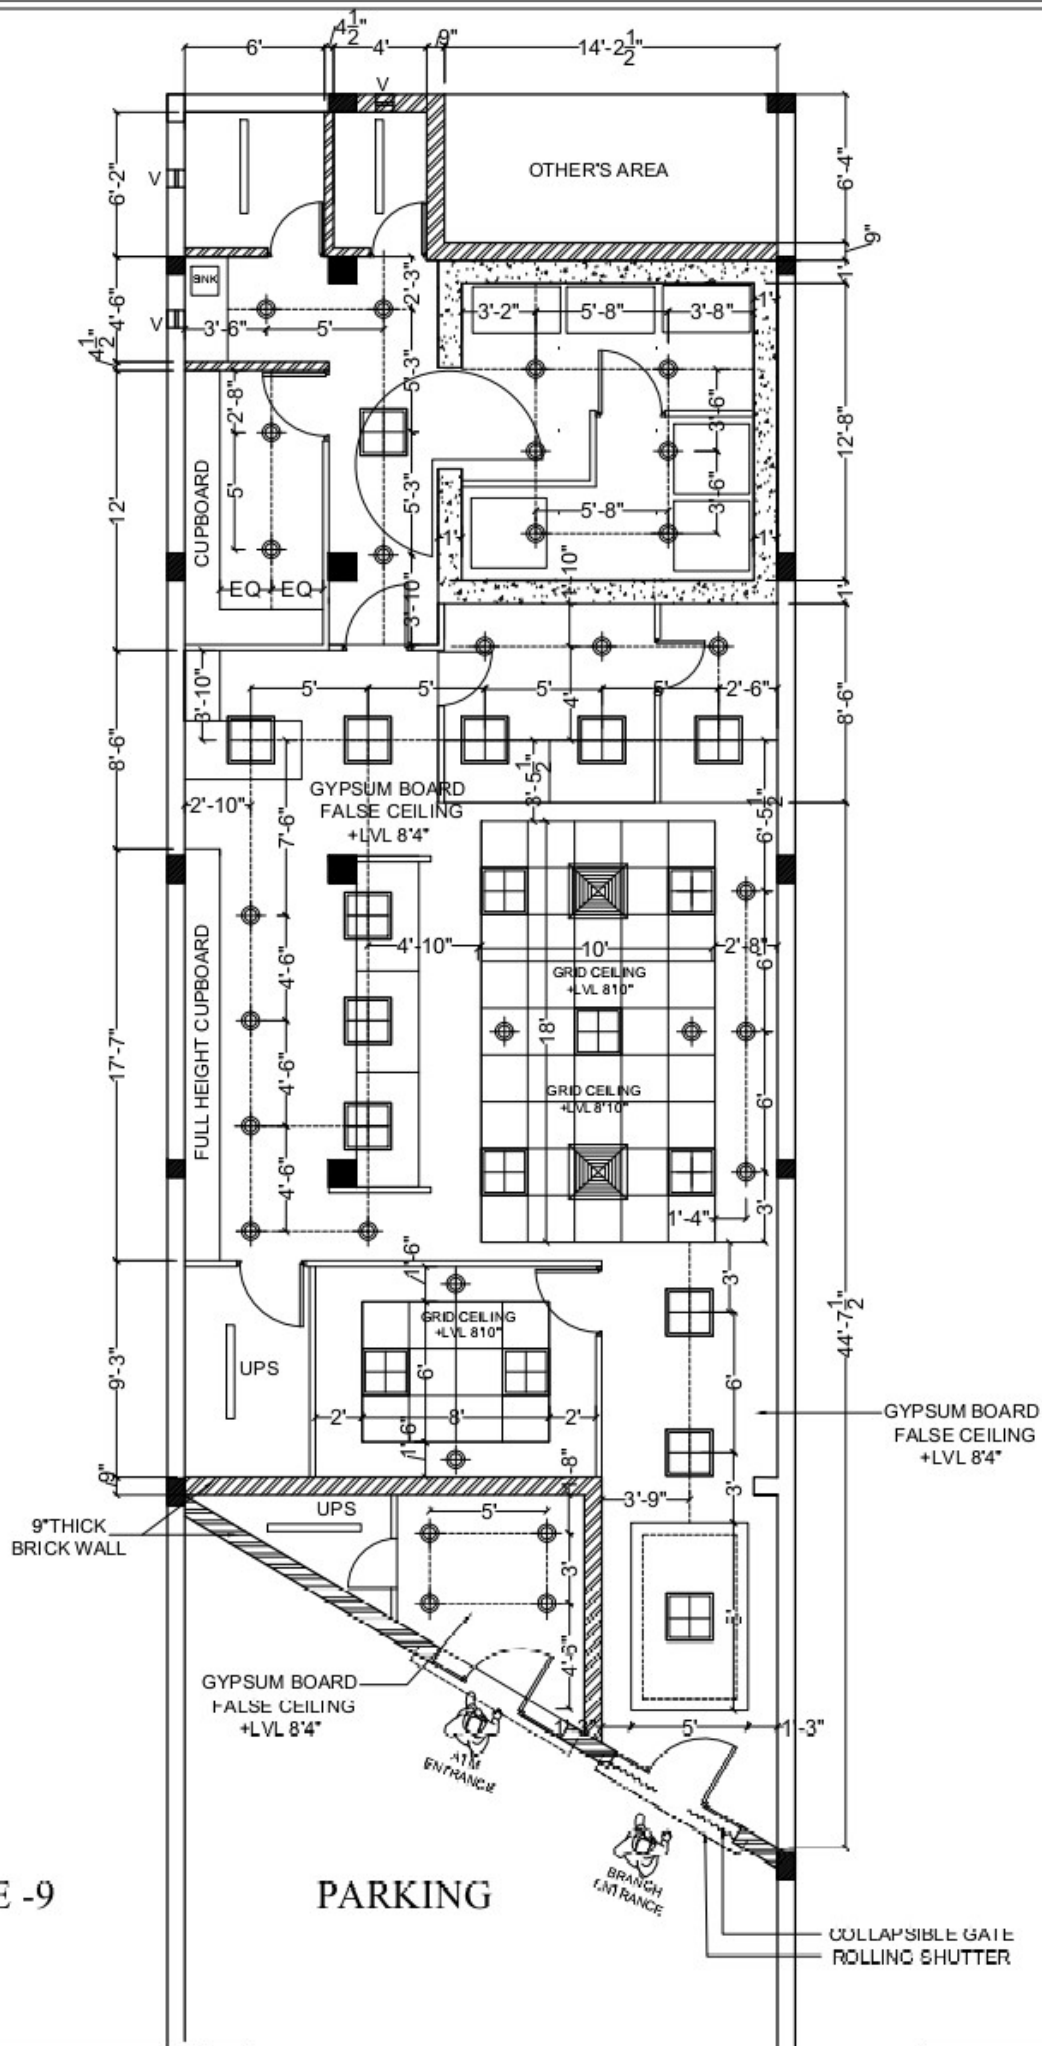

ALTERNATE -9

PARKING

PROPOSED INTERIOR PLAN FOR THE PREMISES
OF **BANK OF BARODA,**
PILAKHUA BRANCH, UP

INVERTED CEILING PLAN


SCALE N T S DATE 25-09-2023 DEALT BY Ravi OKD BY LA.



dg no
W-02



COMPETENT DESIGNERS
ARCHITECTS, ENGINEERS & INTERIOR DESIGNERS
A-5A, POCKET - F MAYUR VIHAR PHASE-II,
DELHI-110091
Email - competentarchitects@gmail.com.

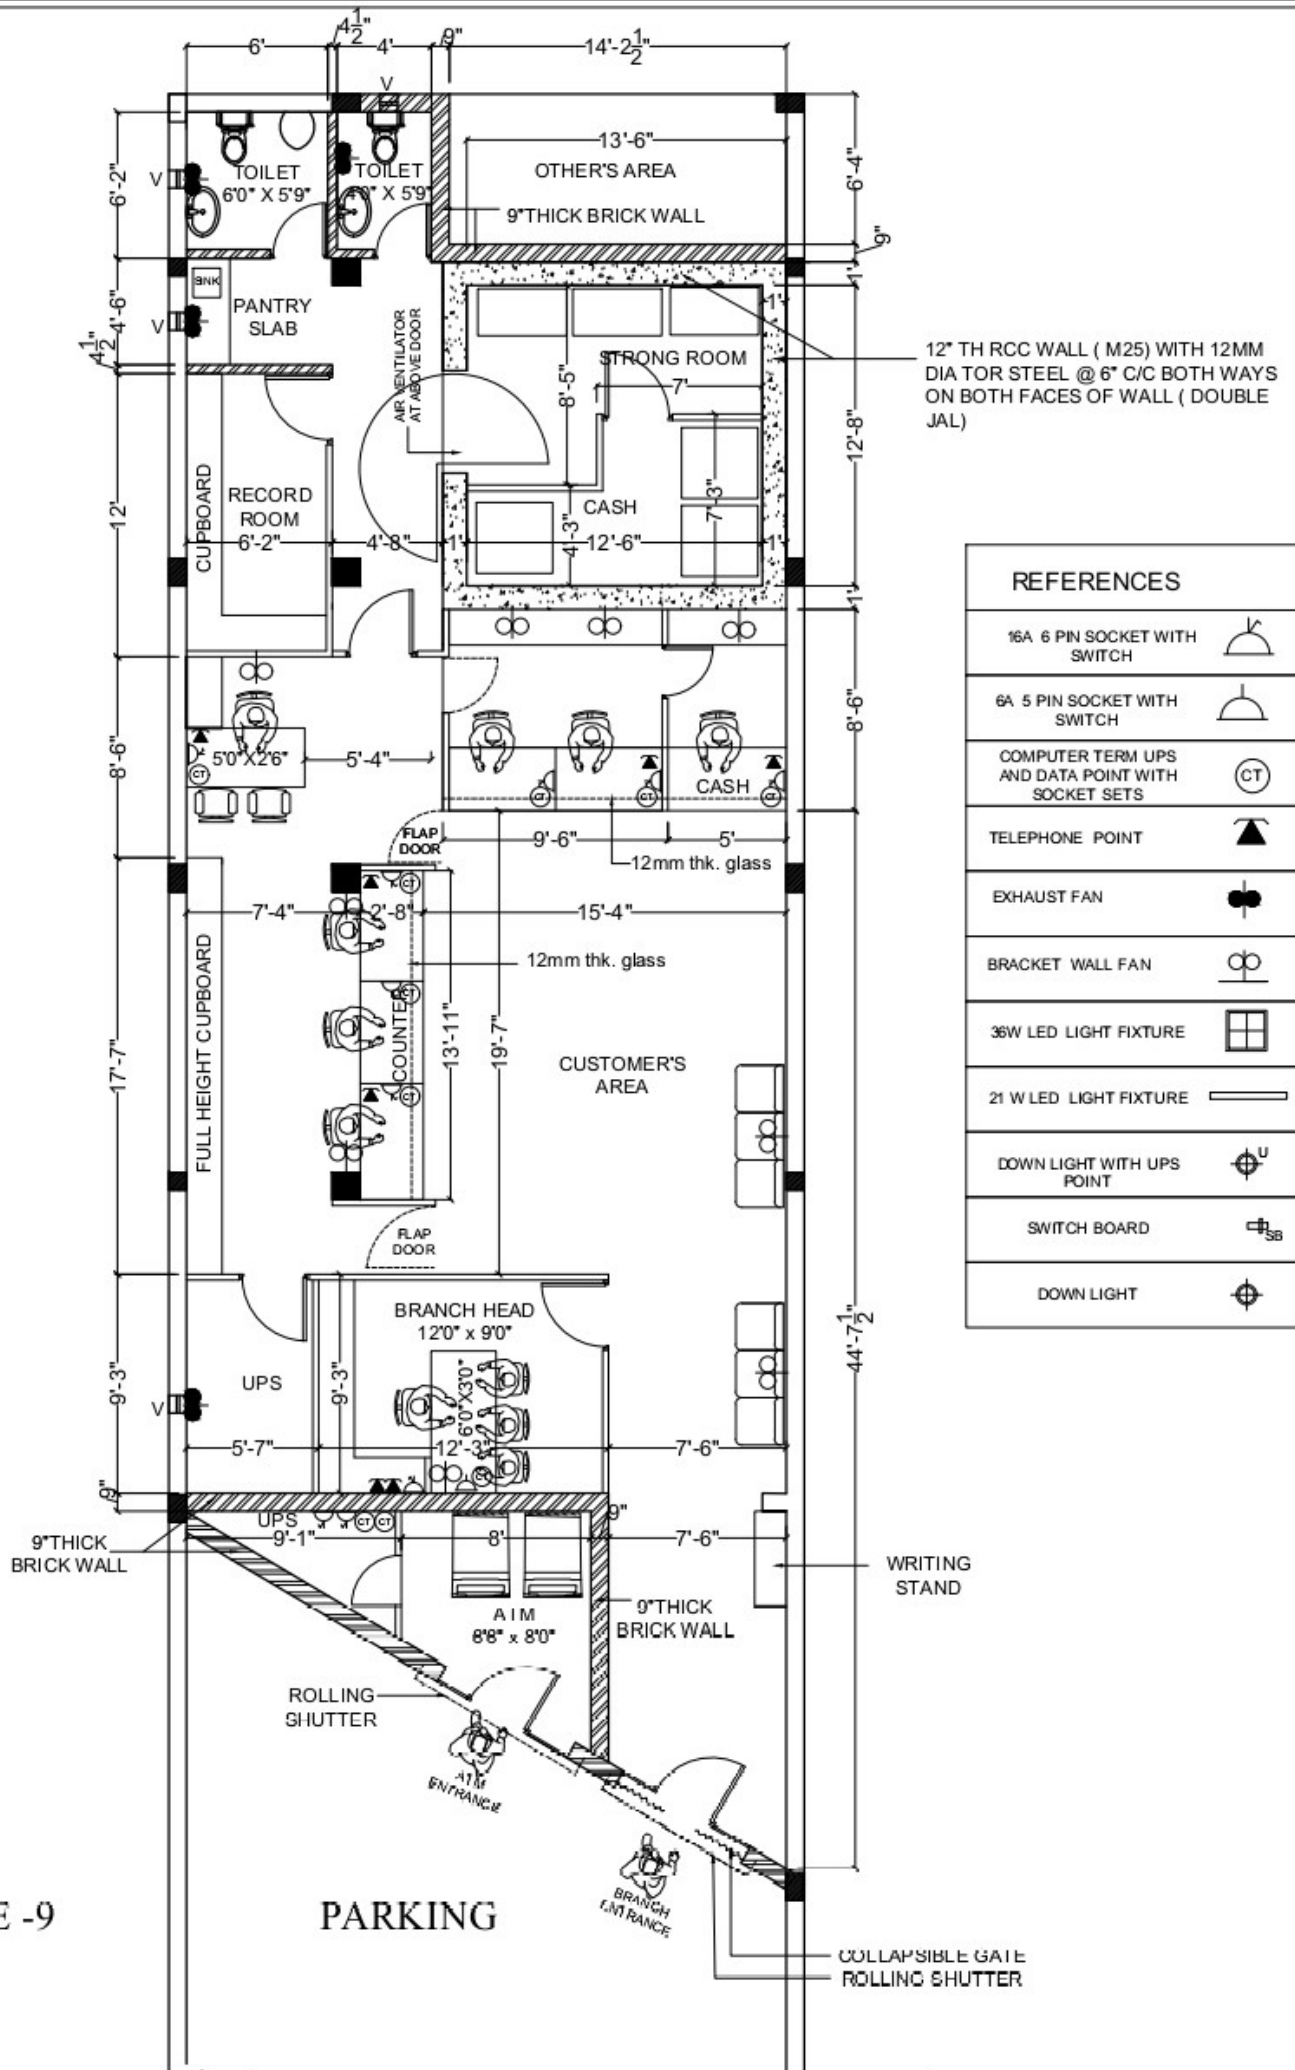

ALTERNATE -9

PARKING

PROPOSED INTERIOR PLAN FOR THE PREMISES
OF **BANK OF BARODA,**
PILAKHUA BRANCH, UP

ELECTRICAL LAYOUT PLAN (GROUND FLOOR)


SCALE N T S DATE 25-09-2023 DEALT BY Ravi OKD BY LA.



W-03



COMPETENT DESIGNERS
ARCHITECTS, ENGINEERS & INTERIOR DESIGNERS
45-A, POCKET - F MAYUR VIHAR PHASE II,
DELHI - 110091
Email - competentarchitects@gmail.com.

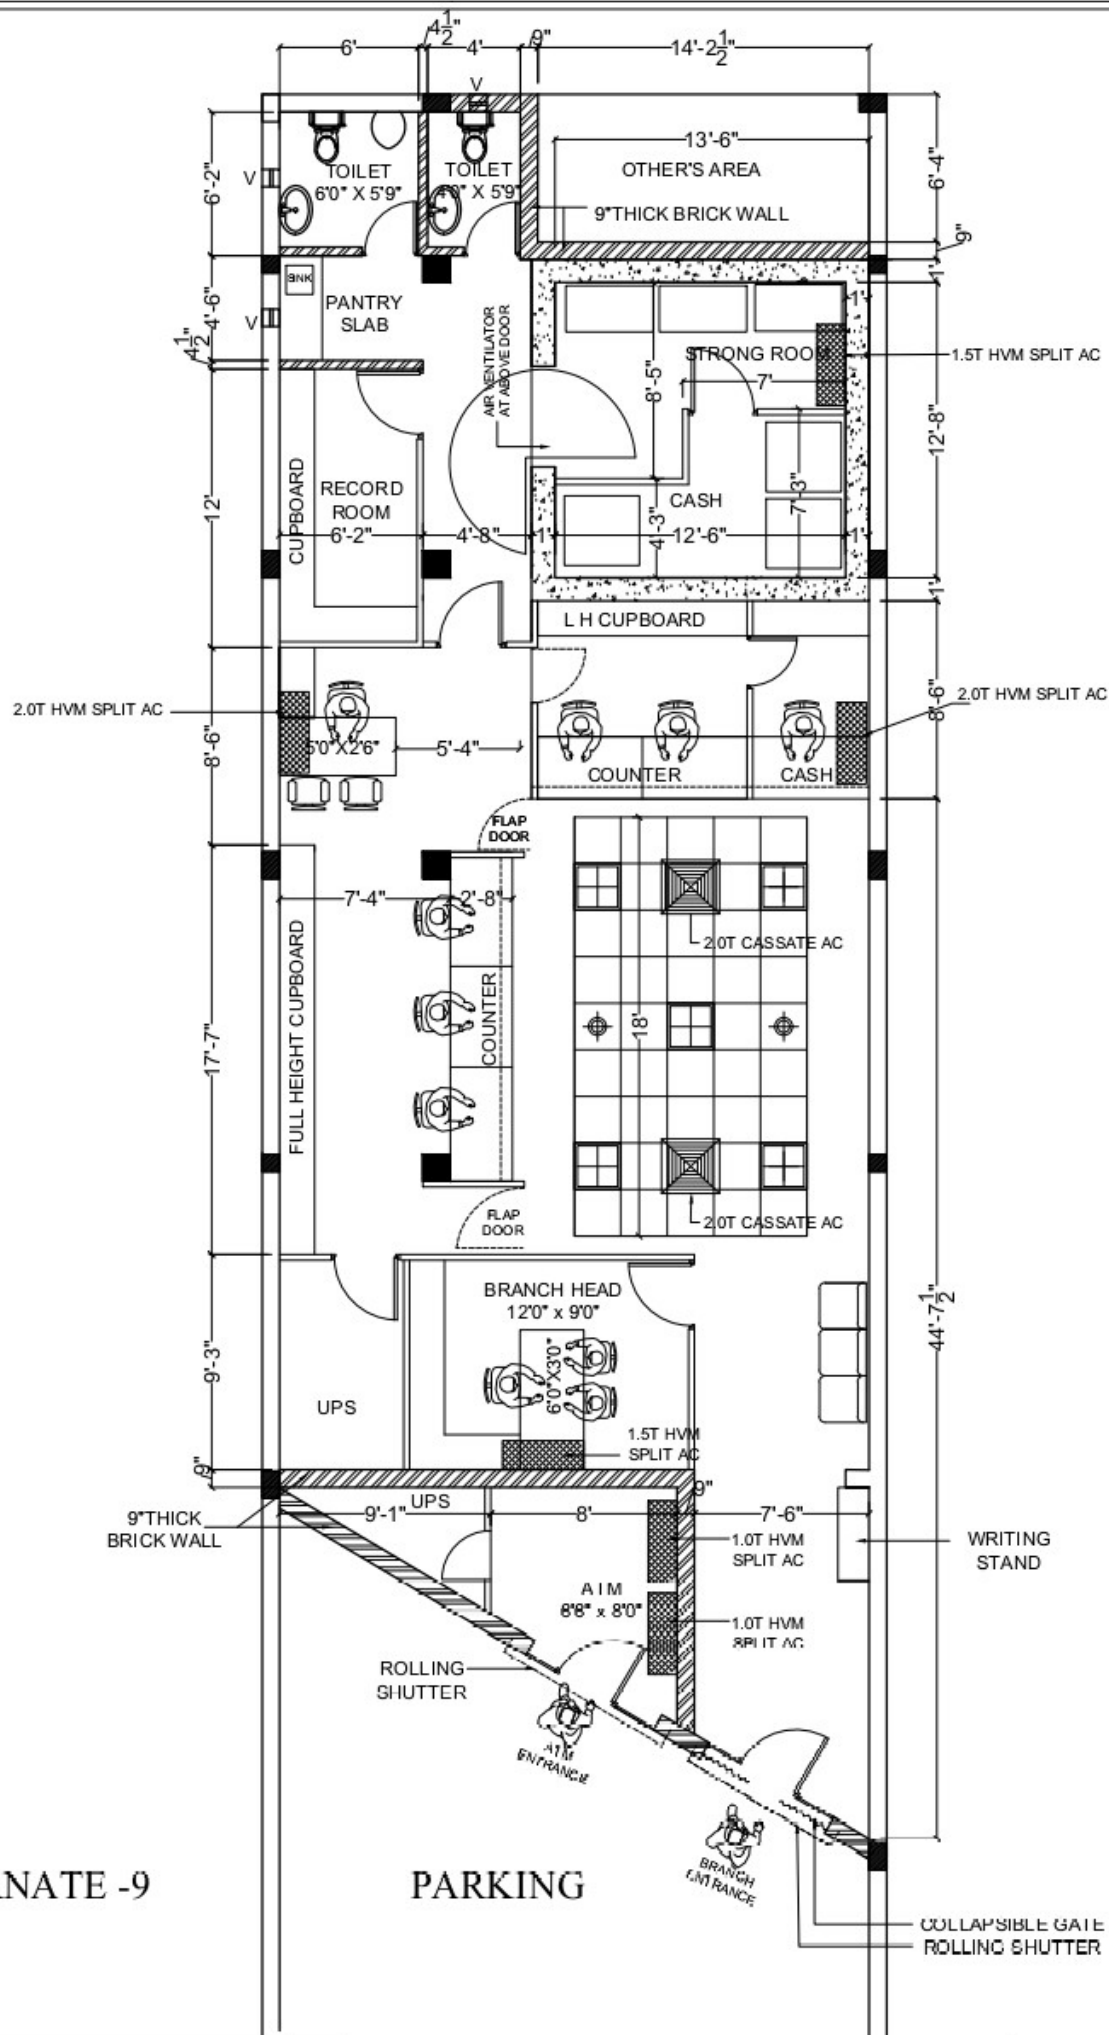

ALTERNATE -9

PARKING

PROPOSED INTERIOR PLAN FOR THE PREMISES
OF **BANK OF BARODA,**
PILAKHUA BRANCH, UP

AC LAYOUT PLAN

SCALE N.T.S. DATE 25-09-2023 DEALT BY Ravi OKD BY LA.



W-04



COMPETENT DESIGNERS
ARCHITECTS, ENGINEERS & INTERIOR DESIGNERS
45-A, POCKET - F, MAYUR VIHAR PHASE II,
DELHI - 110091
Email - competentarchitects@gmail.com.